


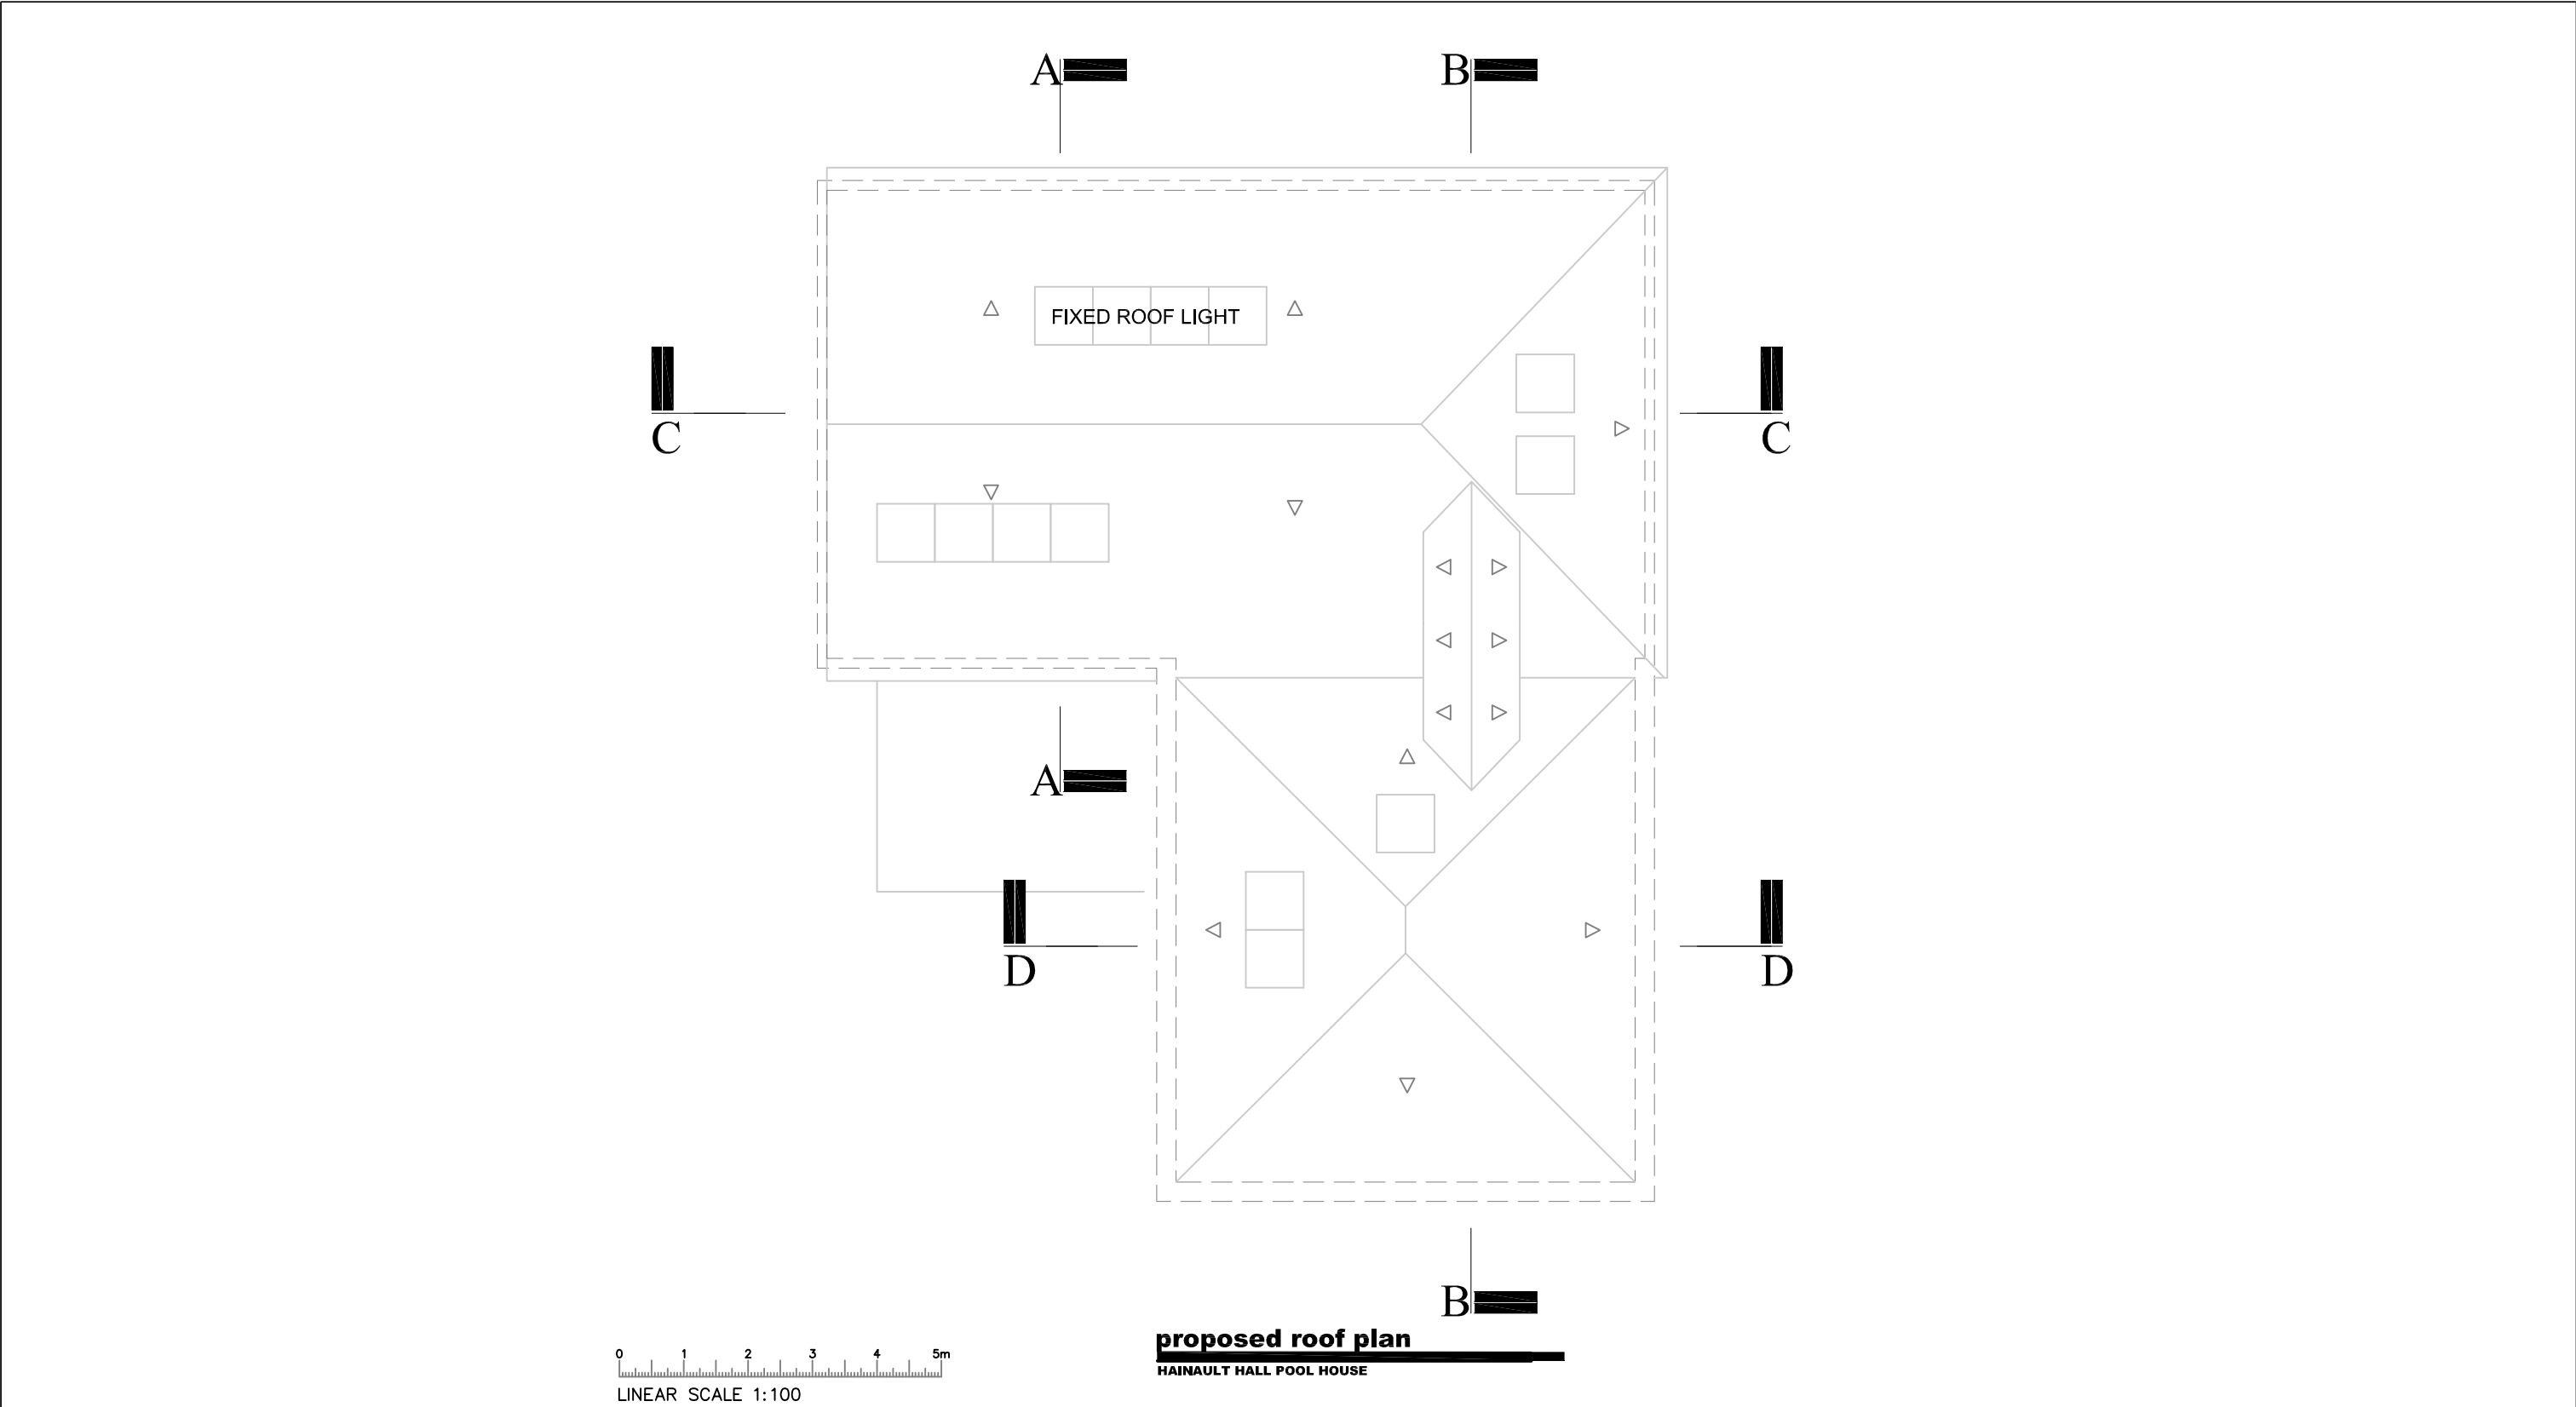

NOTES REVISION A: 1. ROOFLIGHTS REVISED.	PROJECT: PROPOSED DEVELOPMENT TO HAINAULT HALL POOL HOUSE, 173 LAMBOURNE ROAD, CHIGWELL, ESSEX, IG7 6JU.		ARCHITECTS: ARCHEXEL 6 MALCOLM WAY, LONDON, E11 1PW T: +44 (0) 7816 236529 E: archexel@gmail.com		DRWG. TITLE	
					PROPOSED ROOF PLAN	
					DRAWN	CA
	CHECKED	CA				
	SCALE	1 :100 @ A3				
	DATE: FEBRUARY, 2018	SHEET NO				
	DS-08A					