
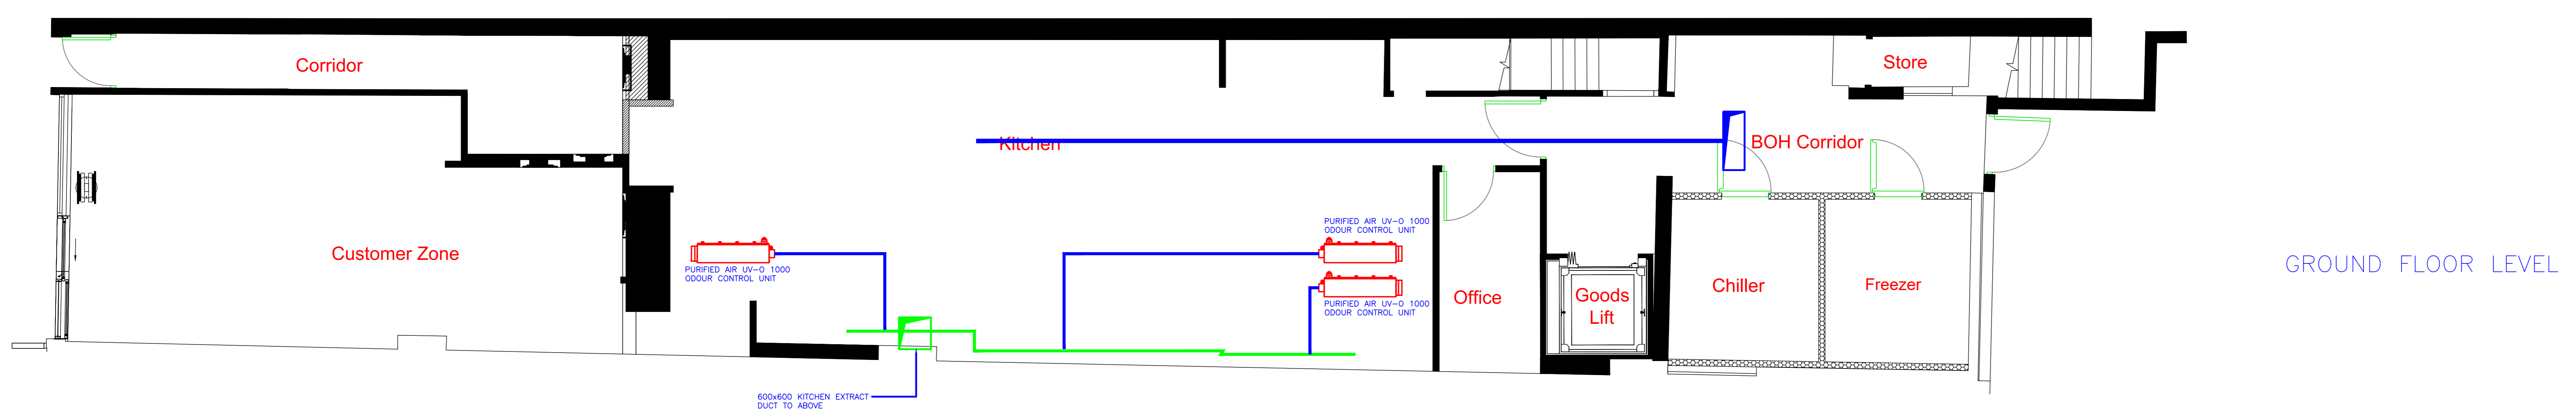
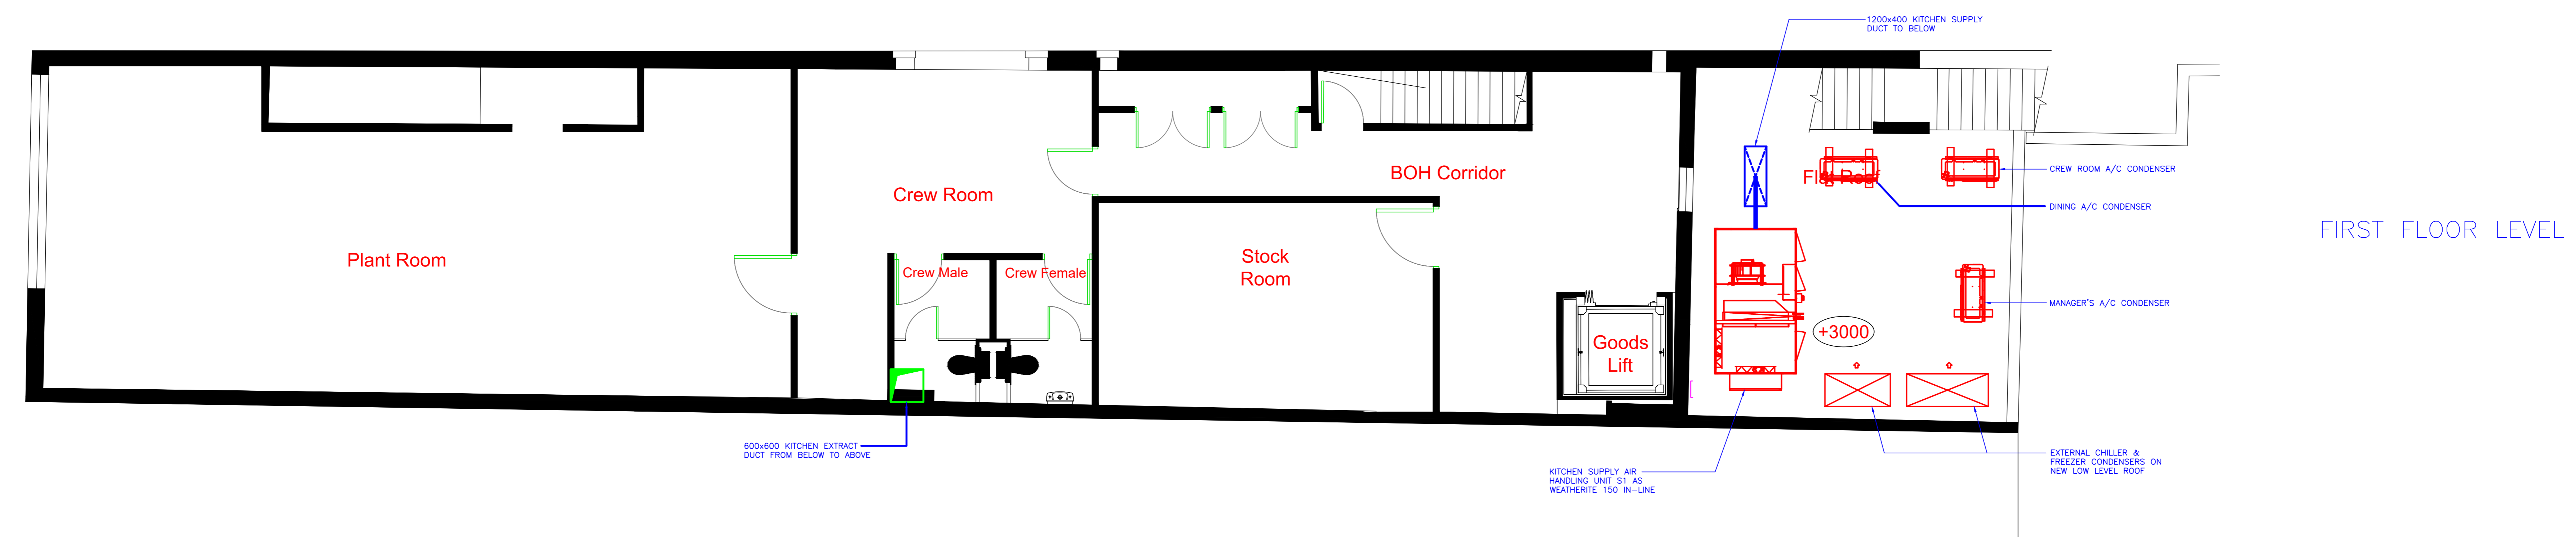


McDonald's


NOTES

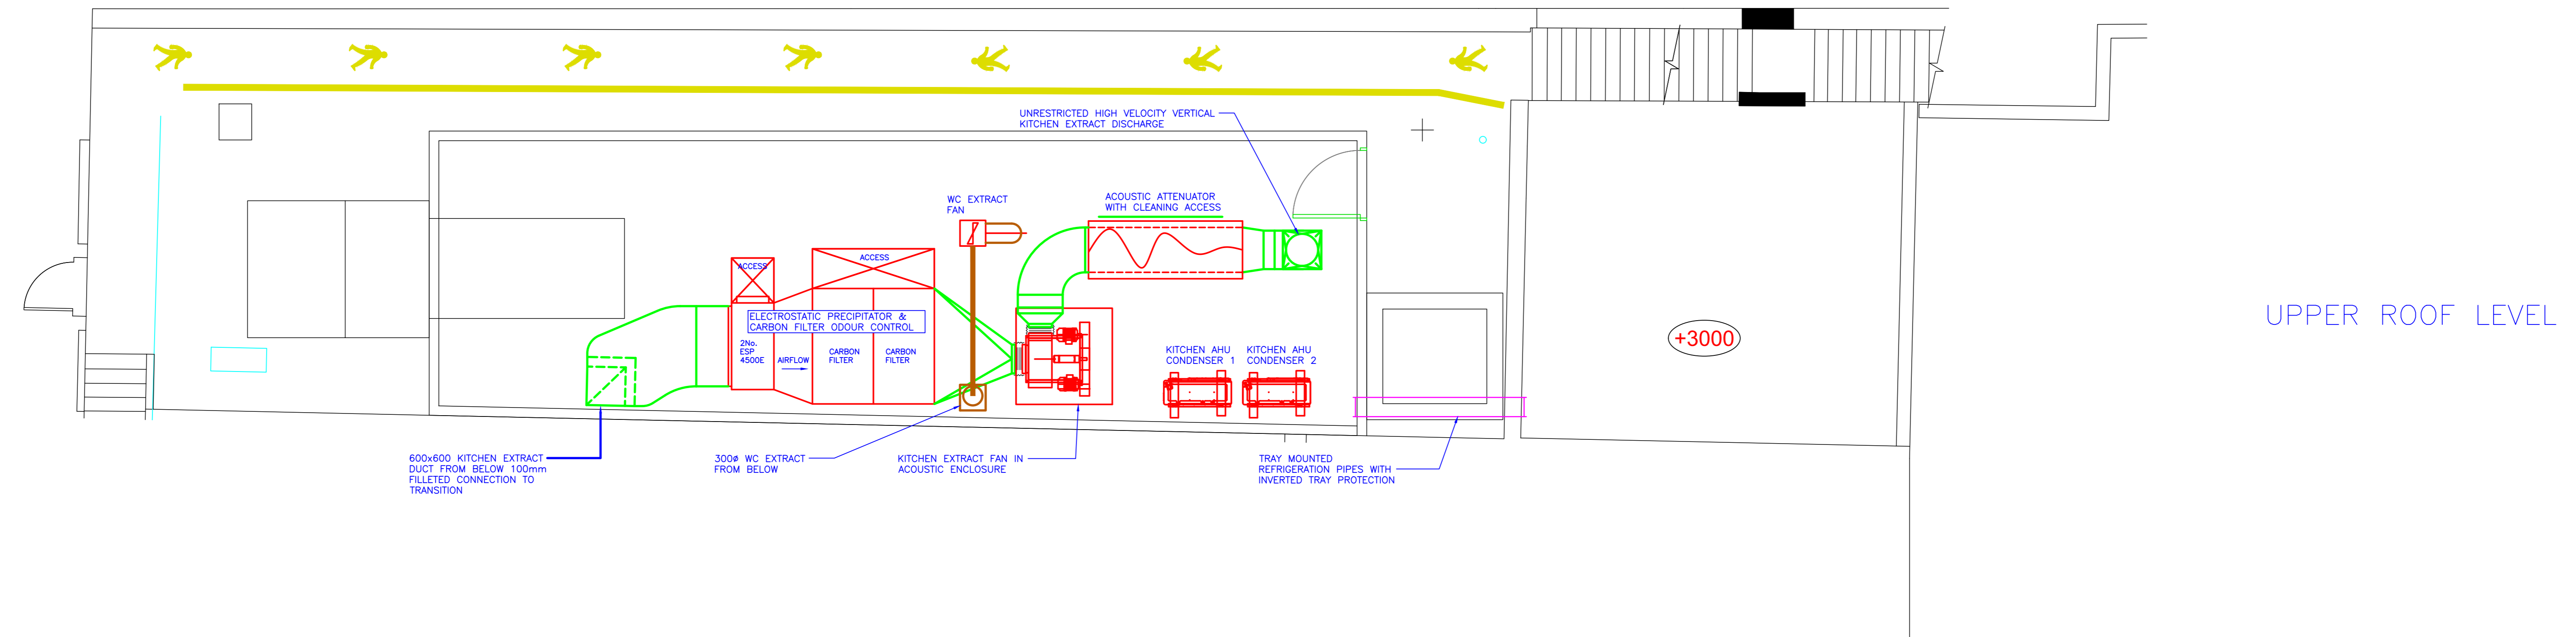

BASE DRAWINGS

AMENDMENTS

REF	DATE	DESCRIPTION
A	JUN18	AMENDED TO COMMENTS
B	JUL19	AMENDED FOR LIFT OVERRUN

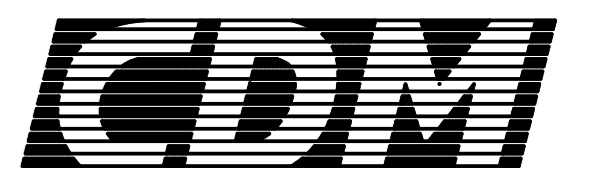

PARTNERSHIP
 10A ALBION STREET, DUNSTABLE, BEDS LU6 1SA
 Tel : 01582 472457 Fax : 01582 472458
 Email : office@cdmpartnership.co.uk

PROJECT
 McDONALD'S RESTAURANT
 202 HIGH STREET
 LOUGHTON

TITLE
 HVAC PLANNING DRAWING

DATE	DRWN
JUNE 2019	ACS
SCALE	DRG No.
1:500@A0	8382 M 1010 B